


STORAGE BUILDING FLOOR PLAN - ELECTRICAL

SCALE: 1/4" = 1'-0"

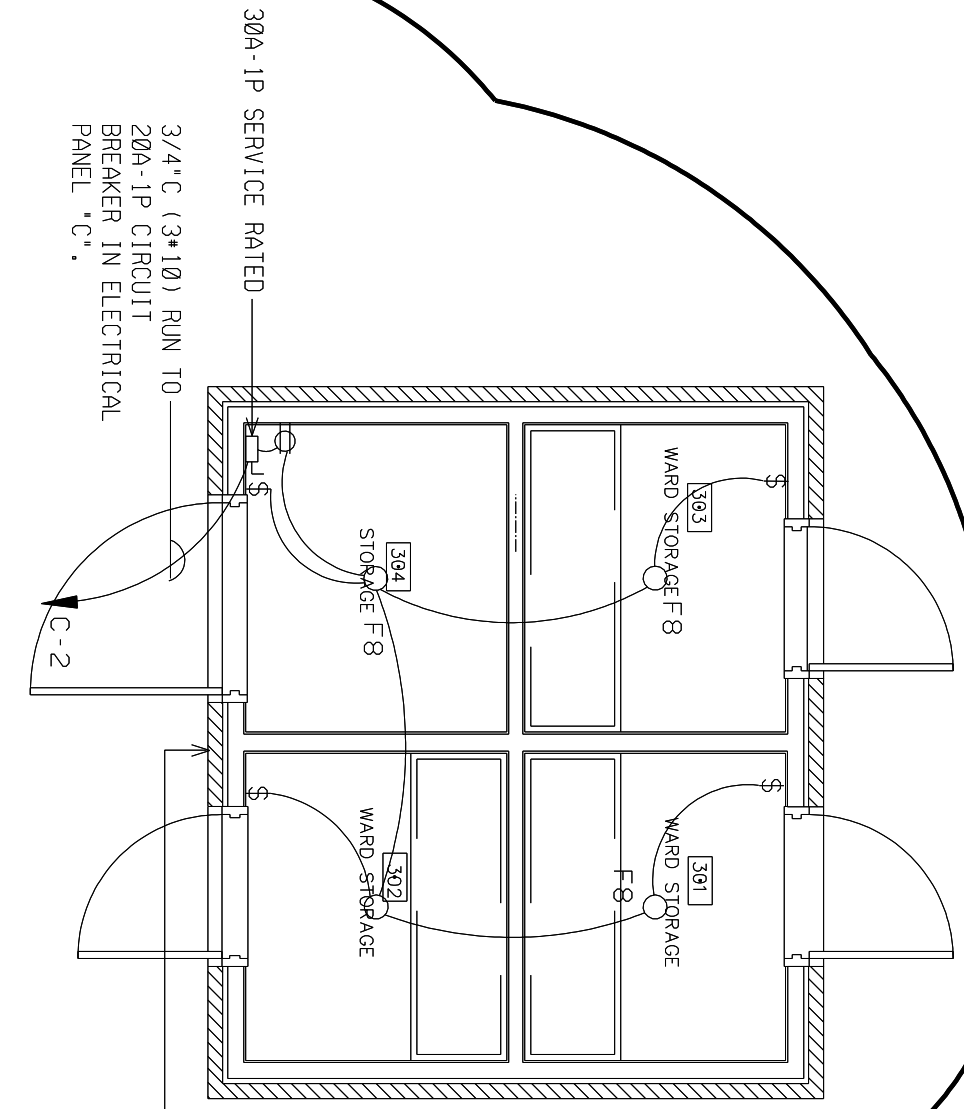

PROVIDE A LITHONIA "TWS" SERIES LIGHT FIXTURE OR EQUAL BY APPROVED OTHER. FIXTURE SHALL BE BRONZE IN COLOR WITH A 42 WATT COMPACT FLOURESCENT LAMP AND BUILT-IN PHOTOCELL. IT SHALL BE SURFACE MOUNTED AT 9 FT TO BOTTOM OF FIXTURE AND OPERATE AT 120 VOLTS.

SHEET E103
EQUIPMENT PLATFORM - ELECTRICAL

Project Number: 0805
Plan Series: FAY-170-02 [07]-02
Property Number: 500-0881-08020101

Project for:
**THE CHURCH OF
JESUS CHRIST
OF LATTER-DAY SAINTS**

**THOMASTON, GA
BRANCH**
JONESBORO, GA STAKE
HWY. 36 North of
ROCK HILL SCHOOL RD.
THOMASTON, GA. 30286



American Institute Of Architects AIA
 • 401 CHERRY STREET SUITE 700
 MACON, GEORGIA 31201 -USA-
 • TEL 478 750 7117
 • FAX 478 750 9192

DATE 03/08/10
SHEET NO.
AD-14C